

DIAG. NO. REVISION DATE
A-1 02-25-8

13C1

13B5

13S1



13D1

13C31

13C5

13D51

● Water Bottle Refill Station

● Standard Water Fountain

DWG. NO: **A-3**
REVISION DATE: 08-22-2018
SCALE:
DESIGN BY: PLA
BLDG. CODE: **CK**
CHECKED BY: JCD

RECORD FLOOR PLAN
CHOPTANK HALL BUILDING

THIRD FLOOR PLAN

SALISBURY UNIVERSITY
FACI PLANNING & CAPITAL PROJECTS
ARCHITECTURAL AND ENGINEERING SERVICES
1101 CAMDEN AVENUE
SALISBURY, MARYLAND 21801
410-543-6215

4B2

4A1

4B1

4C1

4D1

4E1

4C4

4C5

4D5


4C2

DWG. NO.: **A-4**
 REVISION DATE: 08-22-2018
 SCALE: $\frac{1}{8}"=1'$
 DESIGN BY: PLA
 BLDG. CODE: CK
 CHECKED BY: JCD

RECORD FLOOR PLAN
 CHOPTANK HALL BUILDING

FOURTH FLOOR PLAN

SALISBURY UNIVERSITY
 FACILITIES PLANNING & CAPITAL PROJECTS
 ARCHITECTURE AND ENGINEERING SERVICES
 1101 CAMDEN AVENUE
 SALISBURY, MARYLAND 21801
 410-543-6215

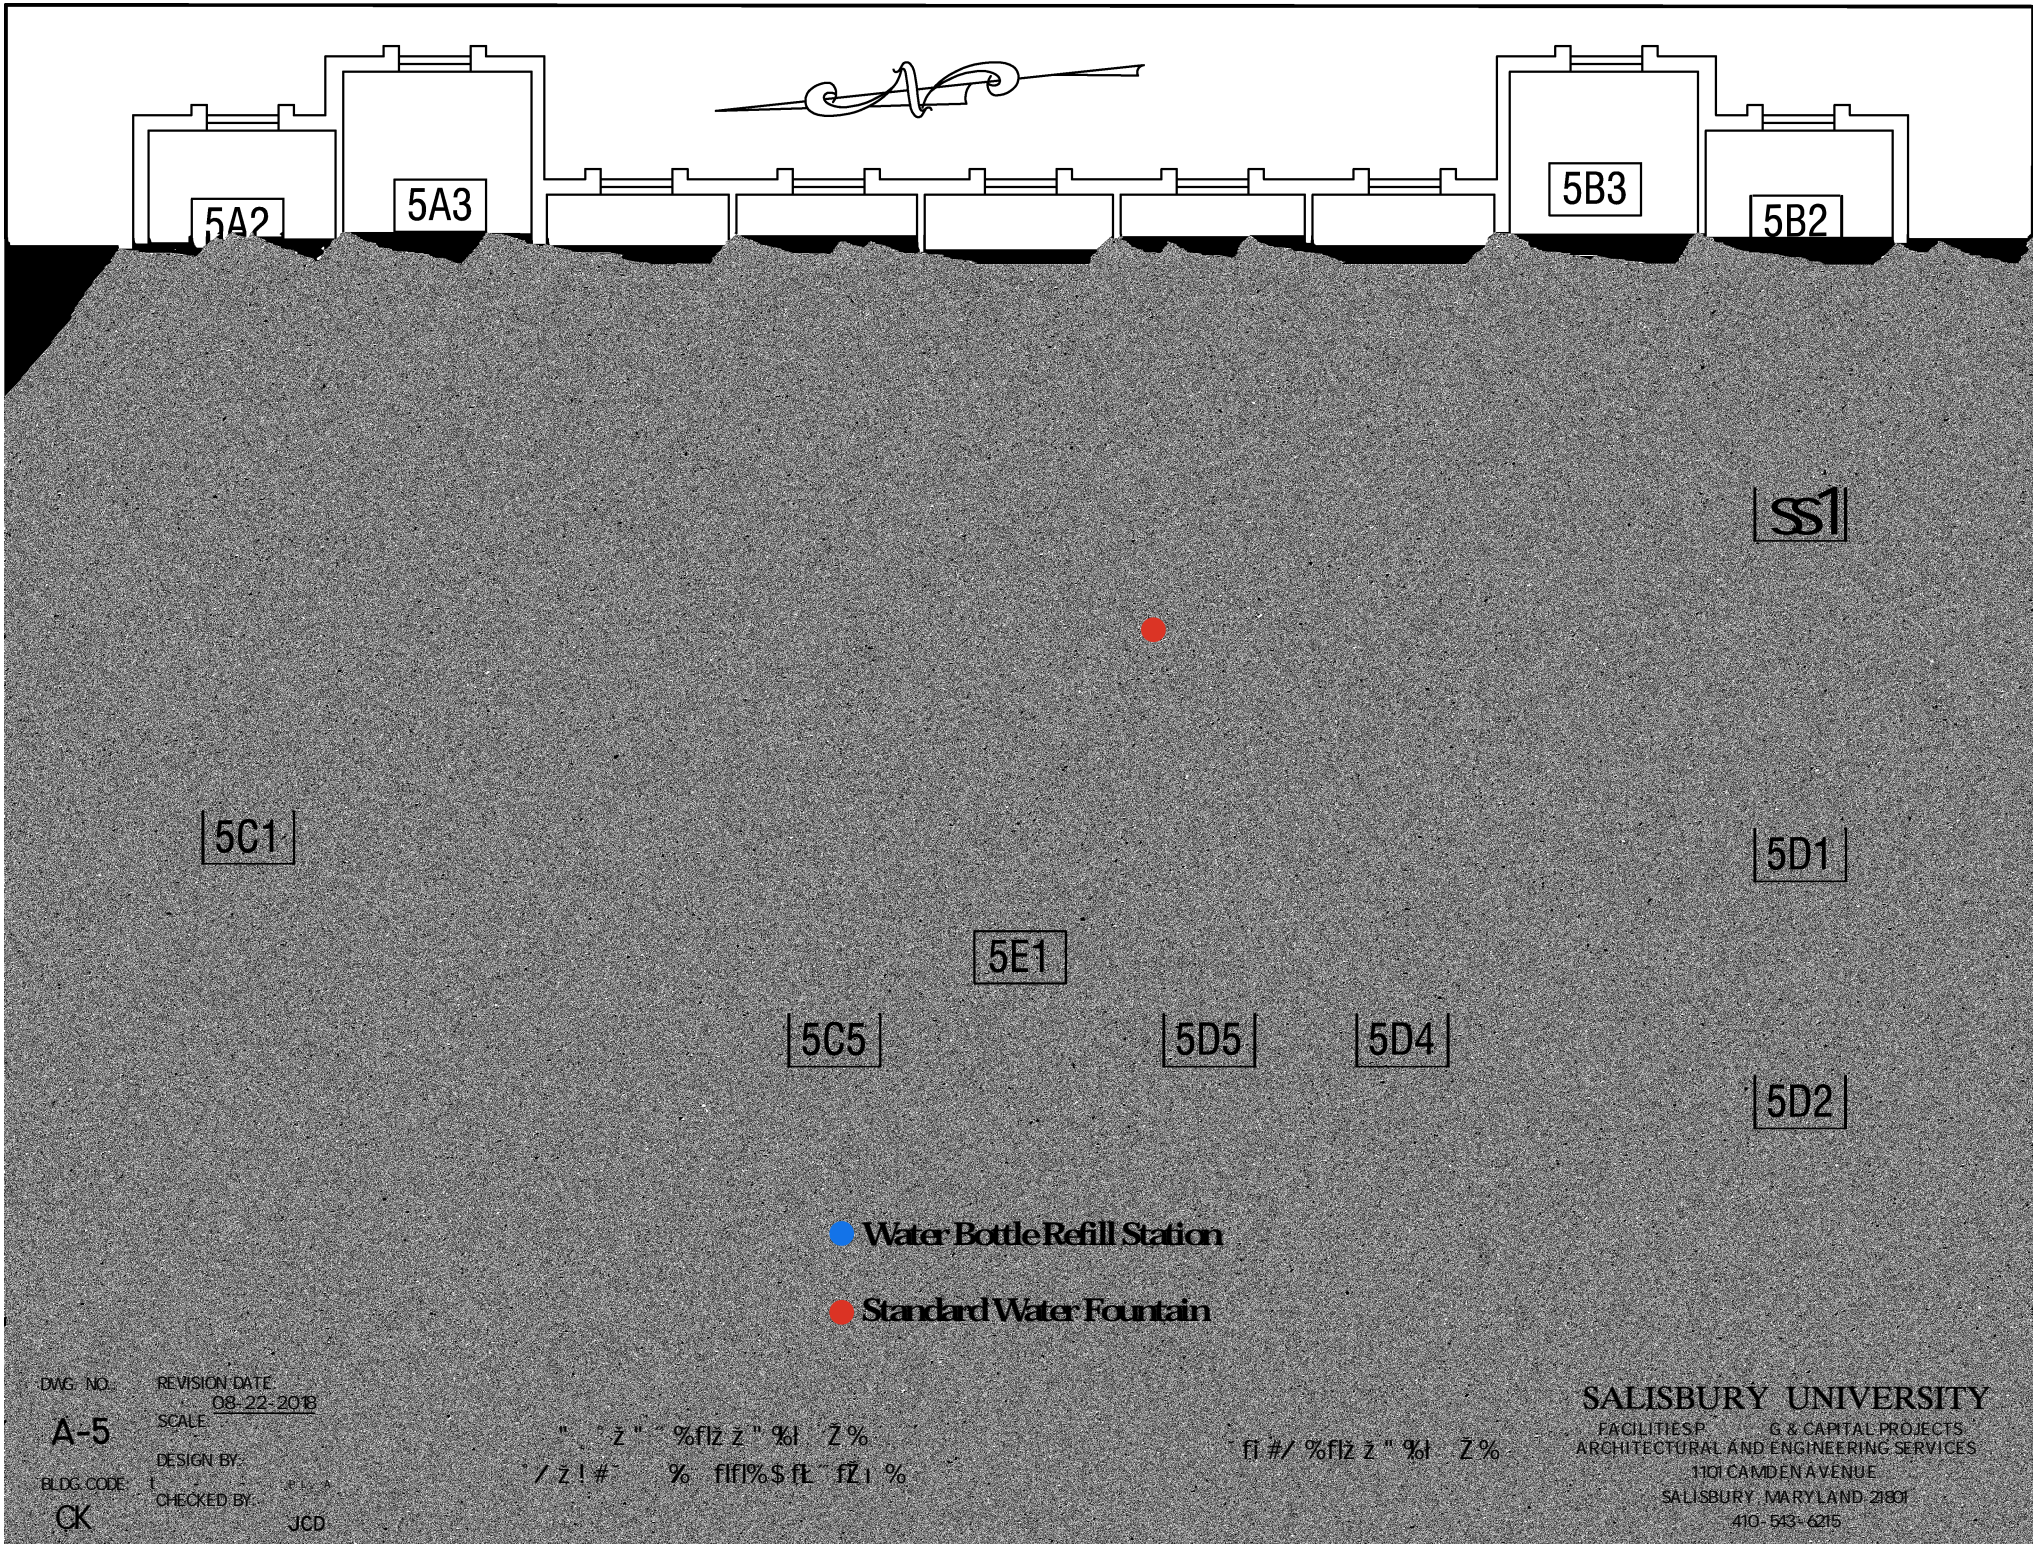

5A2

5A3

5B3

5B2

SS1

5C1

5D1

5E1

5C5

5D5

5D4

5D2

● Water Bottle Refill Station

● Standard Water Fountain

DWG. NO.

A-5

REVISION DATE

08-22-2018

SCALE

DESIGN BY

BLDG. CODE

CHECKED BY

CK

JCD

SALISBURY UNIVERSITY

FACILITIES PLANNING & CAPITAL PROJECTS
ARCHITECTURAL AND ENGINEERING SERVICES

1101 CAMDEN AVENUE

SALISBURY, MARYLAND 21801

410-543-6215



16B31

16

6E1

16C5

16D51

16D41

DWG. NO. **A-6**
 REVISION DATE **08-22-2018**
 SCALE **1"=1'**
 DESIGN BY **PLA**
 BLDG. CODE **CK**
 CHECKED BY **JCD**

RECORD FLOOR PLAN
 CHOPTA HALL BUILDING

SIXTH FLOOR PLAN